

JAMES S. JACOBS ARCHITECTS, PLLC

25 WASHINGTON STREET
MONROE, MICHIGAN 48161
TELE: (734) 241-7933
FAX: (734) 241-1181
EMAIL: jsm@jacobssarch.com



Mechanical | Electrical | Plumbing | Technology | Safety
5604 N. Main St. Suite 200
Sylvania, Ohio 43560
PH: (419) 824-2400
FAX (419) 824-2409
www.jdrm.com

GREENWOOD MAINTENANCE
BUILDING ADDITION FOR:

MONROE HOUSING
COMMISSION:
GREENWOOD
TOWNHOUSES
902 GREENWOOD AVENUE
MONROE, MICHIGAN 48162

PROPERTY CONTACT:
NANCY WAIN, EXEC. DIRECTOR
MONROE HOUSING COMMISSION
20 NORTH ROESSLER STREET
MONROE, MICHIGAN 48162
TELEPHONE: (734) 242-5880

FLOOR PLANS
LIGHTING &
POWER

NOT FOR CONSTRUCTION

07-19-2023 ADDENDUM NO. 3
06-23-2023 ADDENDUM NO.1
06-21-2023 BIDS
DATE: ISSUED FOR:

DRAWN RKB
REVIEW'D DTK


20222

E-3



- LIGHTING PLAN NOTES:**
- A. INDICATES CIRCUIT FROM EXISTING PANEL LP-A (TYPICAL).
 - B. INDICATES CIRCUIT NUMBER FROM PANEL LP-B (TYPICAL).
 - C. INDICATES CIRCUIT NUMBER FROM PANEL LP-C (TYPICAL).
 - D. INDICATES WIRED THROUGH PHOTOCELL (TYPICAL).
 - E. INDICATES WIRED THROUGH PHOTOCELL INLINE WITH MASTER EXTERIOR LIGHT SWITCH (TYPICAL).

FLOOR PLAN - LIGHTING
SCALE: 1/8"=1'-0"

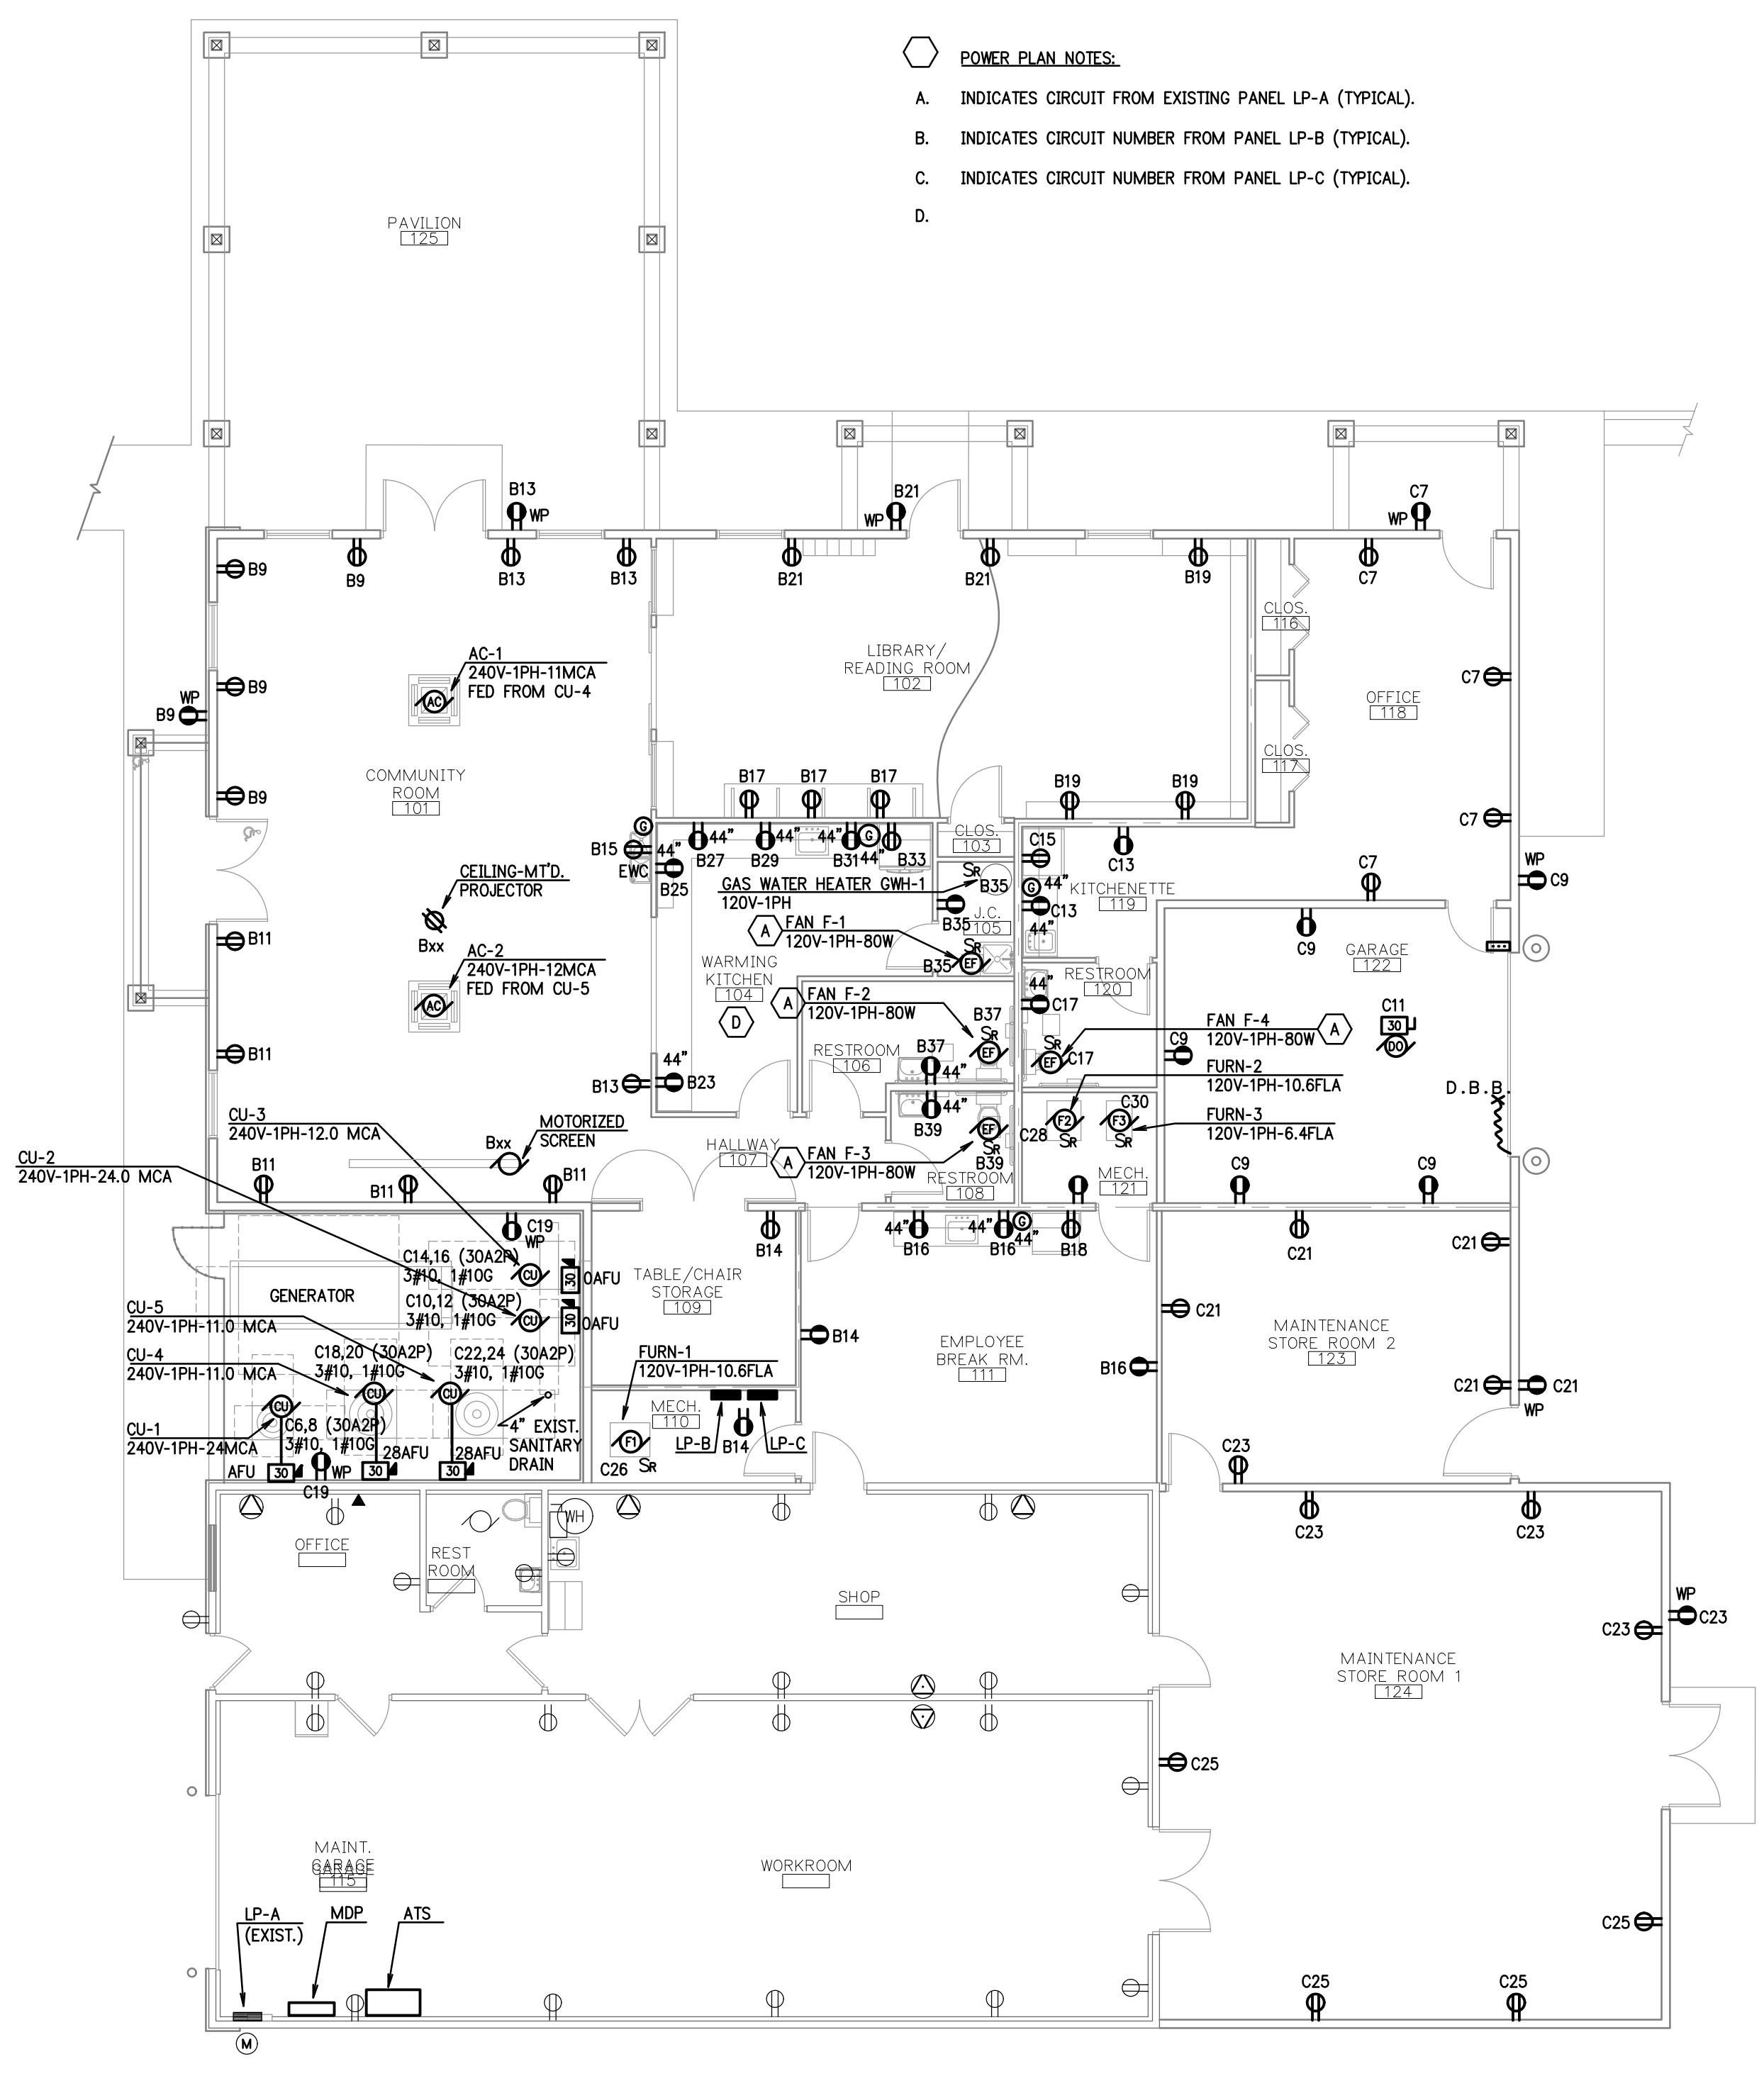

- POWER PLAN NOTES:**
- A. INDICATES CIRCUIT FROM EXISTING PANEL LP-A (TYPICAL).
 - B. INDICATES CIRCUIT NUMBER FROM PANEL LP-B (TYPICAL).
 - C. INDICATES CIRCUIT NUMBER FROM PANEL LP-C (TYPICAL).
 - D.

FLOOR PLAN - POWER
SCALE: 1/8"=1'-0"

- PLAN NOTES:**
- A. INTERLOCK FAN WITH LIGHTS.